


GENERAL SPECIFICATIONS

GUNS, ONLY		GUNS & 4 SIDEWINDERS	
WEIGHT EMPTY	6,950 lbs.	WEIGHT EMPTY	7,570 lbs.
USEFUL LOAD	14,330 "	USEFUL LOAD	14,330 "
GROSS WEIGHT	21,280 "	GROSS WEIGHT	22,160 "
TOP SPEED	654 knots/S.L.	TOP SPEED	630 knots/S.L.
CRUISING SPEED	502 knots/S.L.	CRUISING SPEED	454 knots/S.L.
LANDING SPEED, with flaps	130 knots/15,500 lbs. gross	LANDING SPEED, with flaps	130 knots/15,500 lbs. gross
RATE OF CLIMB	5,130 f.p.m./S.L.	RATE OF CLIMB	4,050 f.p.m./S.L. gross wht.
FUEL CAPACITY	6,650 lbs. (1049 gals.)	FUEL CAPACITY	3 gals.
OIL CAPACITY	1,108 nautical miles	OIL CAPACITY	784 nautical miles
CRUISING RANGE	41,900 feet	CRUISING RANGE	37,700 feet
SERVICE CEILING	250 sq. ft. (BASIC PROJECTED AREA WITH/WITHOUT L.E. FILLET)	SERVICE CEILING	250 sq. ft. (BASIC PROJECTED AREA WITH/WITHOUT L.E. FILLET)
WING AREA	WRIGHT J-65-W-18 7,450 l.s.t. (10,500 l.s.t. WITH AFTERBURNER)	WING AREA	WRIGHT J-65-W-18 7,450 l.s.t. (10,500 l.s.t. WITH AFTERBURNER)
POWER PLANT	4 20 mm RAPID FIRE CANNON &	POWER PLANT	4 20 mm RAPID FIRE CANNON &
NORMAL ARMAMENT	4 AAM INFRA RED HEAT SEEKING SIDEWINDER IA, IC MISSILES	NORMAL ARMAMENT	4 AAM INFRA RED HEAT SEEKING SIDEWINDER IA, IC MISSILES


COLORING NOTES:

ALL PLAN VIEW SURFACES, VERTICAL FIN TO COLOR LINE
 LIGHT GRAY (BATTLESHIP OR GULL GRAY) - MATTE FINISH -
 EXCEPTIONS AS NOTED

ALL UNDERSURFACES - GLOSS WHITE BELOW COLOR LINE
 ONLY EXCEPTIONS, NATIONAL INSIGNIA, LETTERING
 ALL LETTERING - BLACK, DECORE NOTED
 LIGHTNING FLASHES, SQUADRON PERSONALITY
 DECORE, CHROME YELLOW -
 BLACK OUTLINED

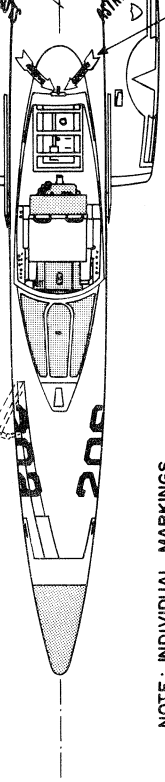


NOTE: INDIVIDUAL MARKINGS
 VARIED WITHIN SQD. VF-33, DRAWING
 PORTRAITS NO. 206 AS IT WAS. OTHERS
 IN SQD. VARIED LITTLE.

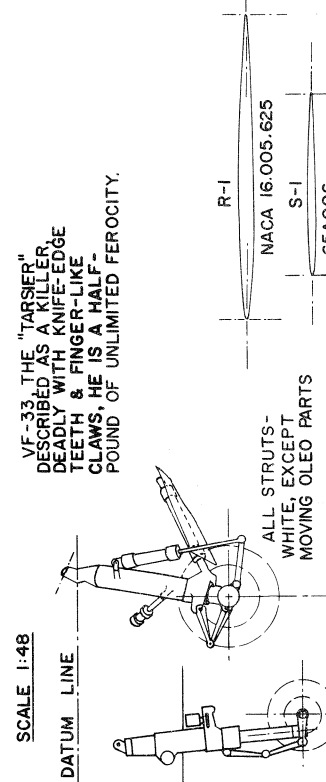


HISTORICAL AVIATION MUSEUM

GRUMMAN FIIF-1 (F-11A) "TIGER"


1959
 SCALE: 1:64
 DRAWN BY: PAUL R. MATT

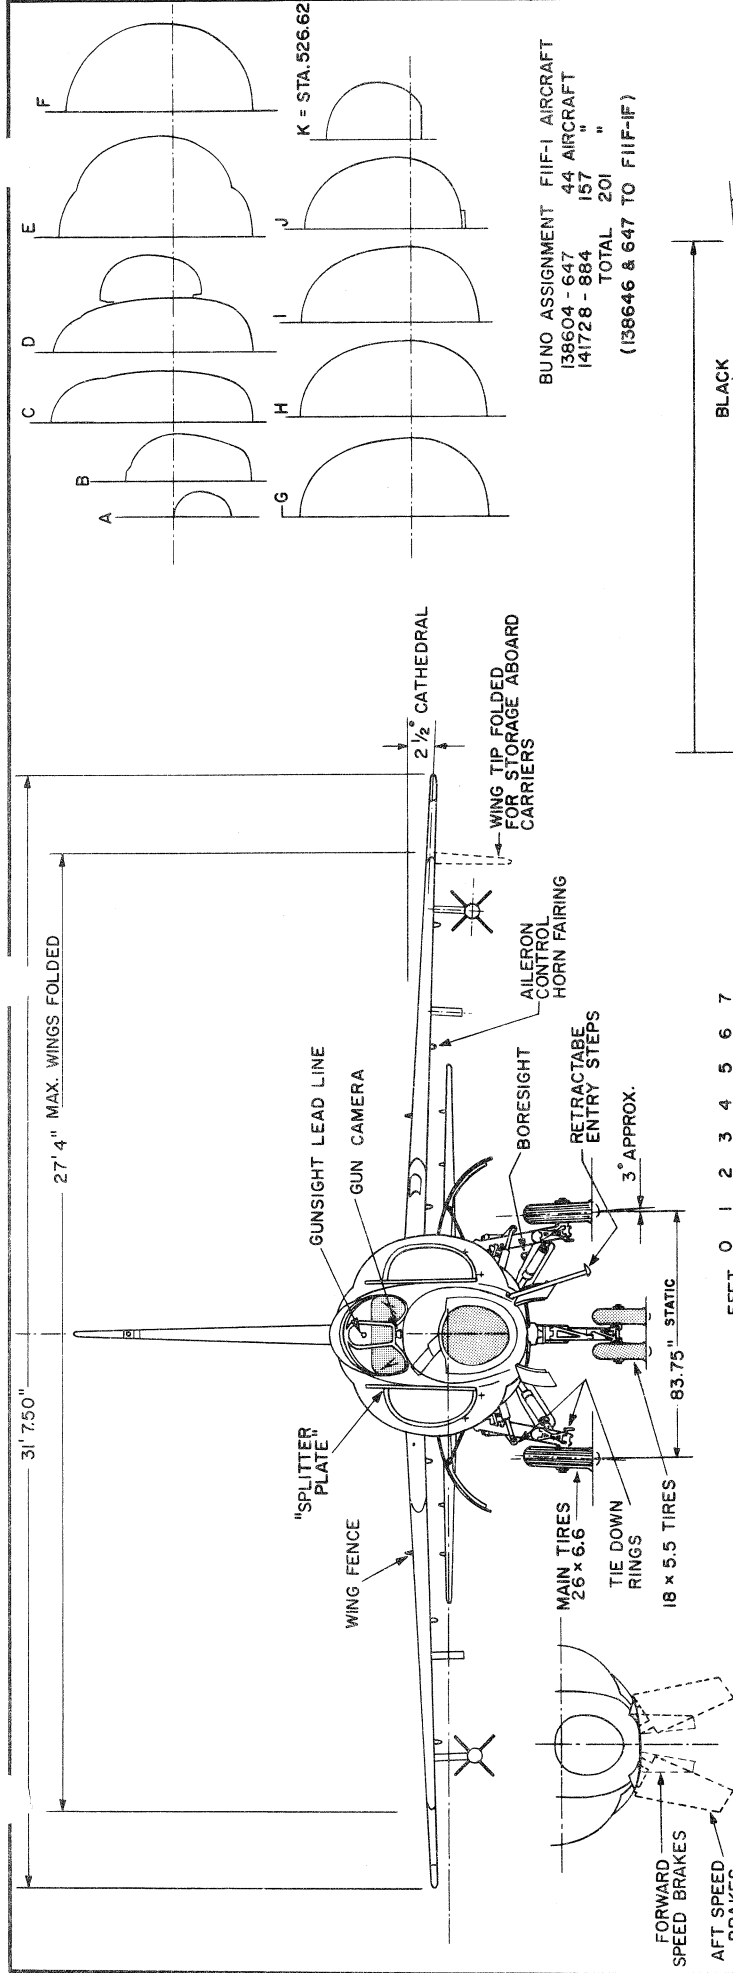

K = STA. 526.62

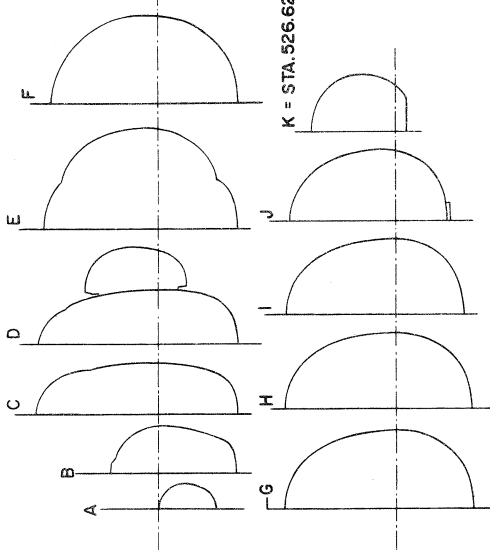

BU NO ASSIGNMENT F11F-1 AIRCRAFT
 138604 - 647 44 AIRCRAFT
 141728 - 884 157 " "
 TOTAL 201 " "
 (138646 & 647 TO F11F-1F)

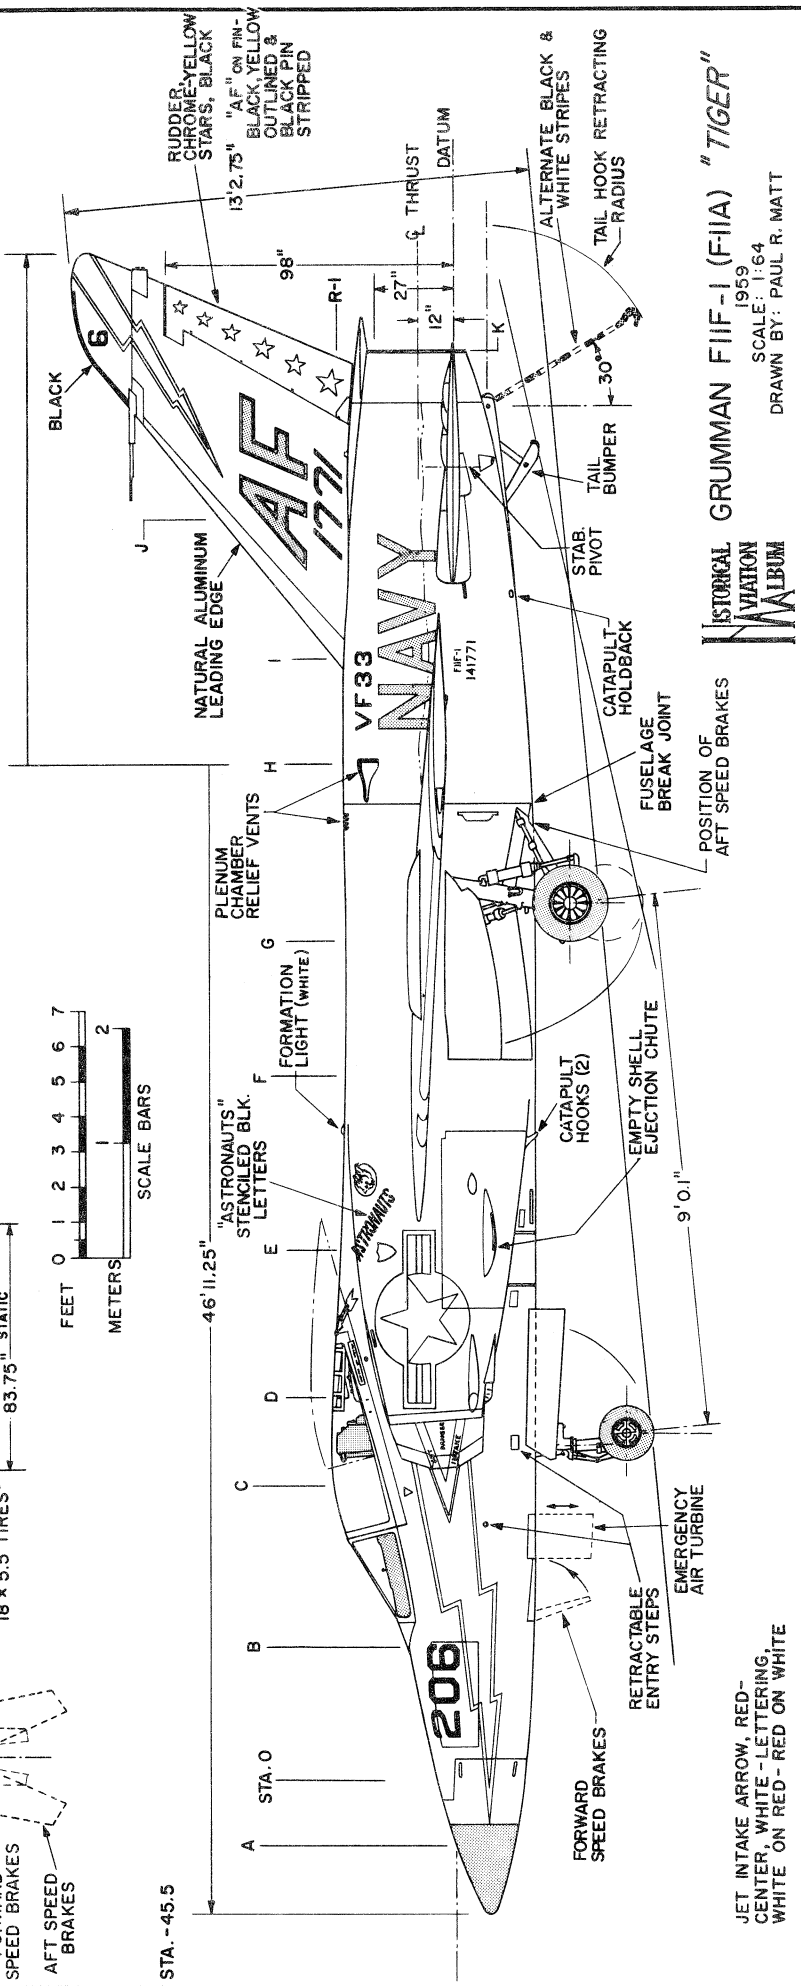

HISTORICAL AVIATION MUSEUM

GRUMMAN F11F-1 (F11A) "TIGER"

1959

SCALE: 1:64

DRAWN BY: PAUL R. MATT

JET INTAKE ARROW, RED - CENTER, WHITE - LETTERING, WHITE ON RED - RED ON WHITE